


**SURVEY NOTES**

- TOPOGRAPHICAL & GPR SURVEY CARRIED OUT BY 3RD PARTY SPECIALIST CONTRACTOR. DOB & ASSOCIATES TAKES NO RESPONSIBILITY FOR ACCURACY OF SURVEY INFORMATION.
- MAIN CONTRACTOR TO ESTABLISH INDEPENDENTLY ORDNANCE DATUM ON SITE FOR LEVELS TO MAIN HEAD DATUM AND CO-ORDINATES FOR SETTING OUT TO NATIONAL GRID.
- MAIN CONTRACTOR TO VERIFY ALL UNDERGROUND SERVICES ON THE SITE INCLUDING ALL ANOMALIES NOTED ON THE GPR SURVEY AND TO TAKE ALL NECESSARY PRECAUTIONS PRIOR TO ANY EXCAVATIONS ON THE SITE.
- REFER TO M&E ENGINEERS DRAWINGS FOR DIVERSION / DEMOLITION OF ALL UNDERGROUND ELECTRICAL CABLES / DUCTS, TELECOM DUCTS, LIGHTING DUCTS, OIL LINES ETC.

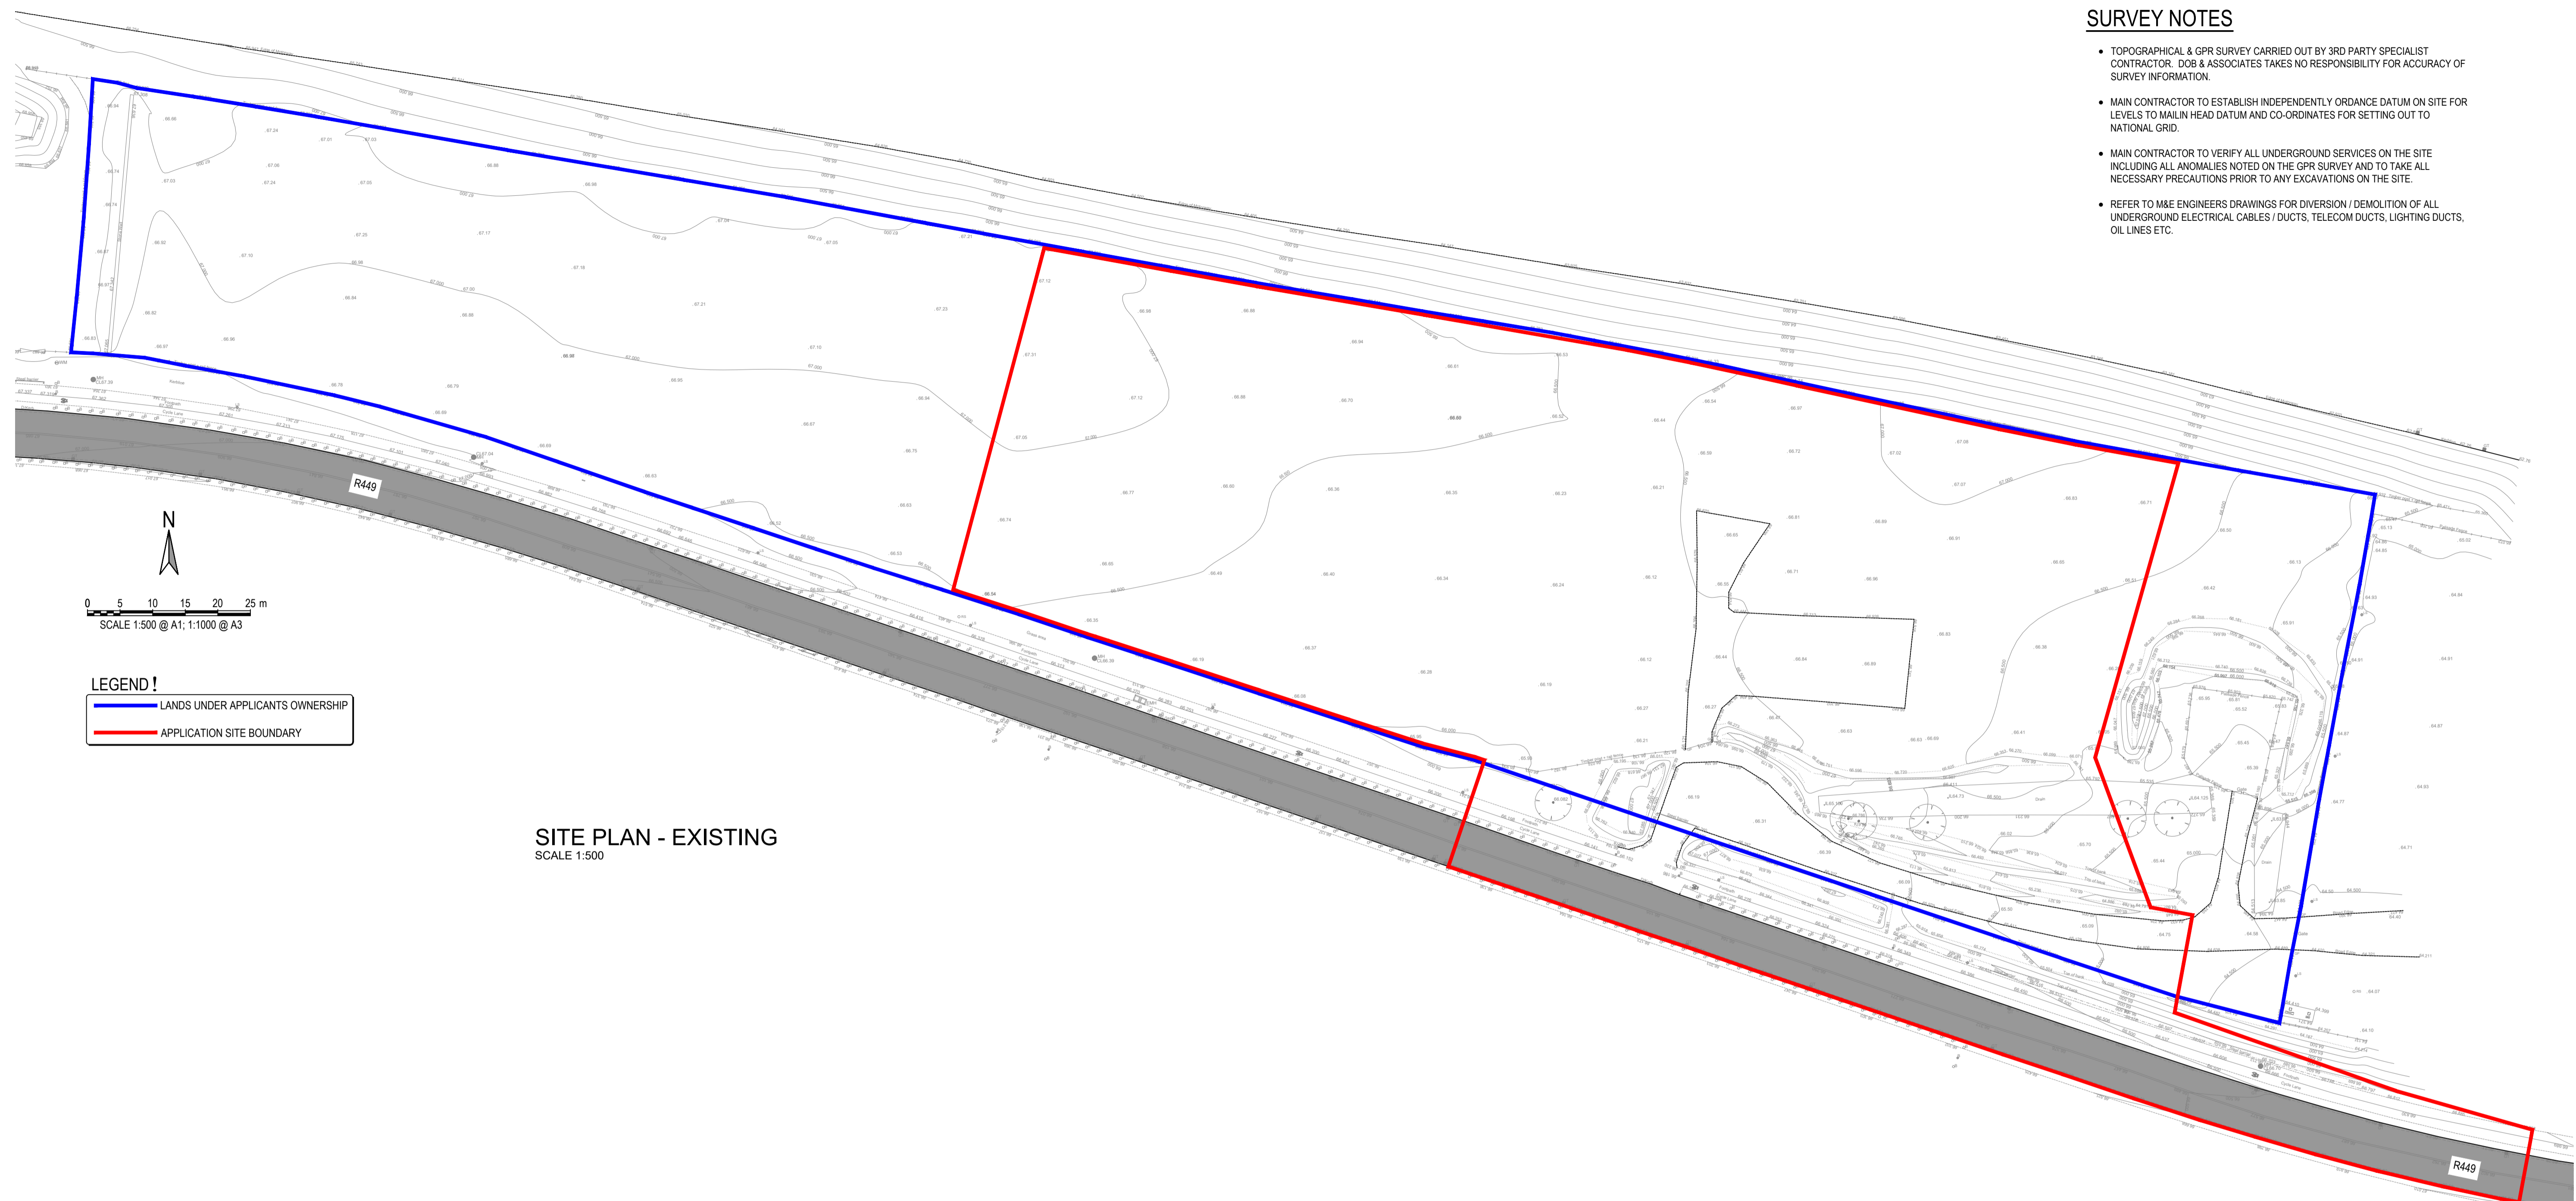

0 5 10 15 20 25 m  
SCALE 1:500 @ A1; 1:1000 @ A3

**LEGEND!**  
— LANDS UNDER APPLICANTS OWNERSHIP  
— APPLICATION SITE BOUNDARY

**SITE PLAN - EXISTING**  
SCALE 1:500

**ISSUED FOR PLANNING**

S2.P03	ISSUED FOR PLANNING	22.02.2019	KD	PD
S2.P02	ISSUED FOR INFORMATION	17.12.2018	KD	PD
S2.P01	ISSUED FOR INFORMATION	05.11.2018	KD	PD
Rev.	Note	Date	Drawn	Check

<b>DONNACHADH O'BRIEN</b> & ASSOCIATES CONSULTING ENGINEERS	UNIT 5C ELM HOUSE MILLENNIUM PARK NAAS CO. KILDARE	PHONE +353 45 984 042 INFO@DOBRIEN-ENGINEERS.IE WWW.DOBRIEN-ENGINEERS.IE
	Client:	

Client: **KILDARE COUNTY COUNCIL**  
 Comhairle Chontae Chill Dara  
 MR. JOE BOLAND, DIRECTOR OF SERVICES  
 WATER SERVICES & ENVIRONMENT



Project: **PROPOSED CIVIC AMENITY CENTRE & WASTE TRANSFER FACILITY AT KILMACREDDOCK UPPER, CASTLETOWN, CELBRIDGE, Co. KILDARE**

Drawing Title: <b>SITE PLAN - EXISTING</b>				
Drawn By: KD	Checked By: PD	Approved By: DOB	Date: AUG 2017	Scale: 1:500
Project Number: DOBA1701	Drawing Number: CIVAMY-DOB- XX-SI- DR-C-0010	Status Code: S2	Rev Number: P03	