

REV.	DATE	AMENDMENT	DRN	APPD

STATUS **FOR PLANNING (PART 8)**



**Waterman Moylan**  
Engineering Consultants

MARINE HOUSE, CLANWILLIAM PLACE, DUBLIN D02 FY24.  
Tel: (01) 664 8900 Fax: (01) 661 3618  
Email: info@waterman-moylan.ie www.waterman-moylan.ie

CLIENT **KILDARE COUNTY COUNCIL**

ARCHITECT **DEATON LYSAGHT ARCHITECTS**


PROJECT **BEECHGROVE, RATHANAGEN  
KILDARE**

TITLE **PROPOSED DRAINAGE LAYOUT**

DRAWN PJD	DESIGNED BW	APPROVED IW	DATE APR 17
SCALE 1:250 @ A1	JOB NO. 16-124	DRG. NO. P003	REVISION

© 2016. This drawing is copyright. No part of this document may be reproduced or transmitted in any form or stored in any retrieval system of any nature without the written permission of the consulting engineer or copyright holder except as agreed for use on the project for which the document was originally issued.


Ordnance Survey Ireland Licence No. EN 0006016  
© Ordnance Survey Ireland/Government of Ireland.

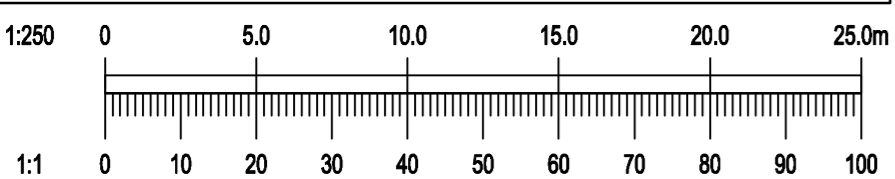

NOTES:

- DO NOT SCALE. USE FIGURED DIMENSIONS ONLY.
- THIS DRAWING IS TO BE READ IN CONJUNCTION WITH ALL OTHER RELEVANT ARCHITECTURAL AND ENGINEERING DRAWINGS.

LEGEND:	
	EXISTING SURFACE WATER PIPE AND MANHOLE
	EXISTING FOUL SEWER PIPE AND MANHOLE
	PROPOSED FOUL WATER SEWER WITH PIPE SIZE, GRADE, MANHOLE REF. AND INVERT LEVEL
	PROPOSED SURFACE WATER SEWER WITH PIPE SIZE, GRADE, MANHOLE REF. AND INVERT LEVEL
	PROPOSED FOUL WATER PRIVATE DRAIN AND INSPECTION CHAMBER
	PROPOSED SURFACE WATER PRIVATE DRAIN AND INSPECTION CHAMBER
	EXISTING DRAINAGE TO BE DECOMMISSIONED
	PROPOSED GULLY AND CONNECTION
	PROPOSED PERMEABLE PAVING
	PROPOSED ATTENUATION STORAGE

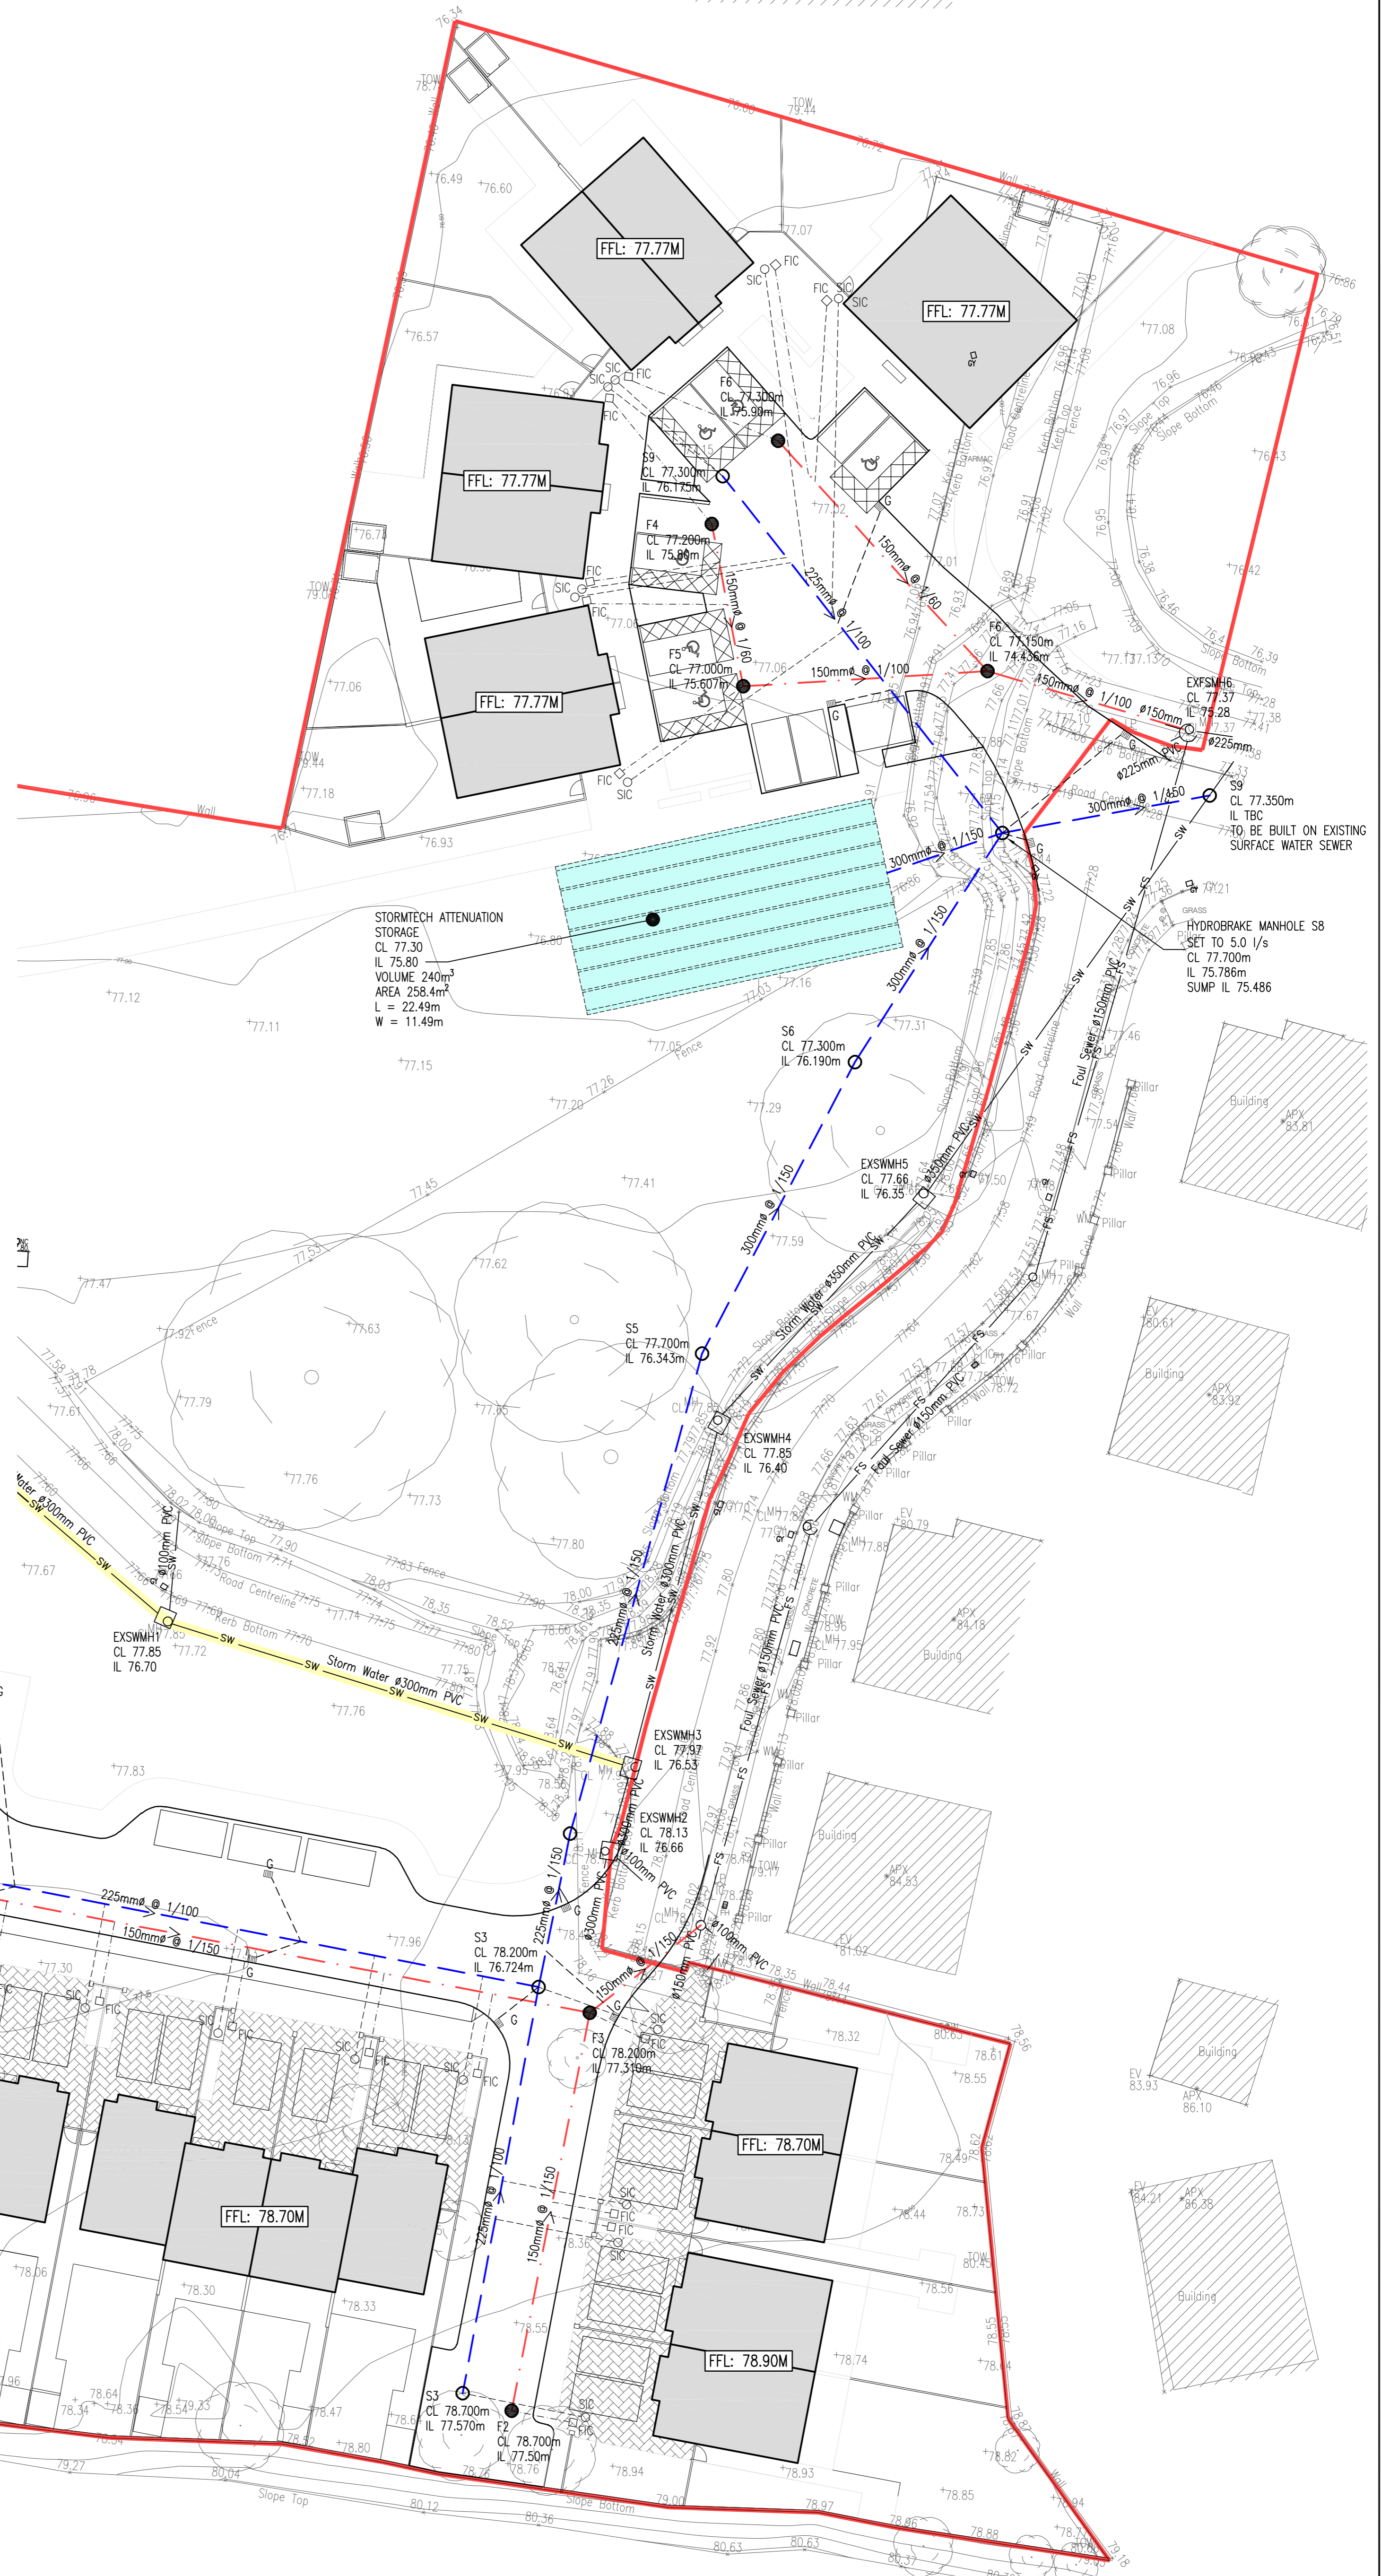

**PROPOSED DRAINAGE LAYOUT**

SCALE 1:250